
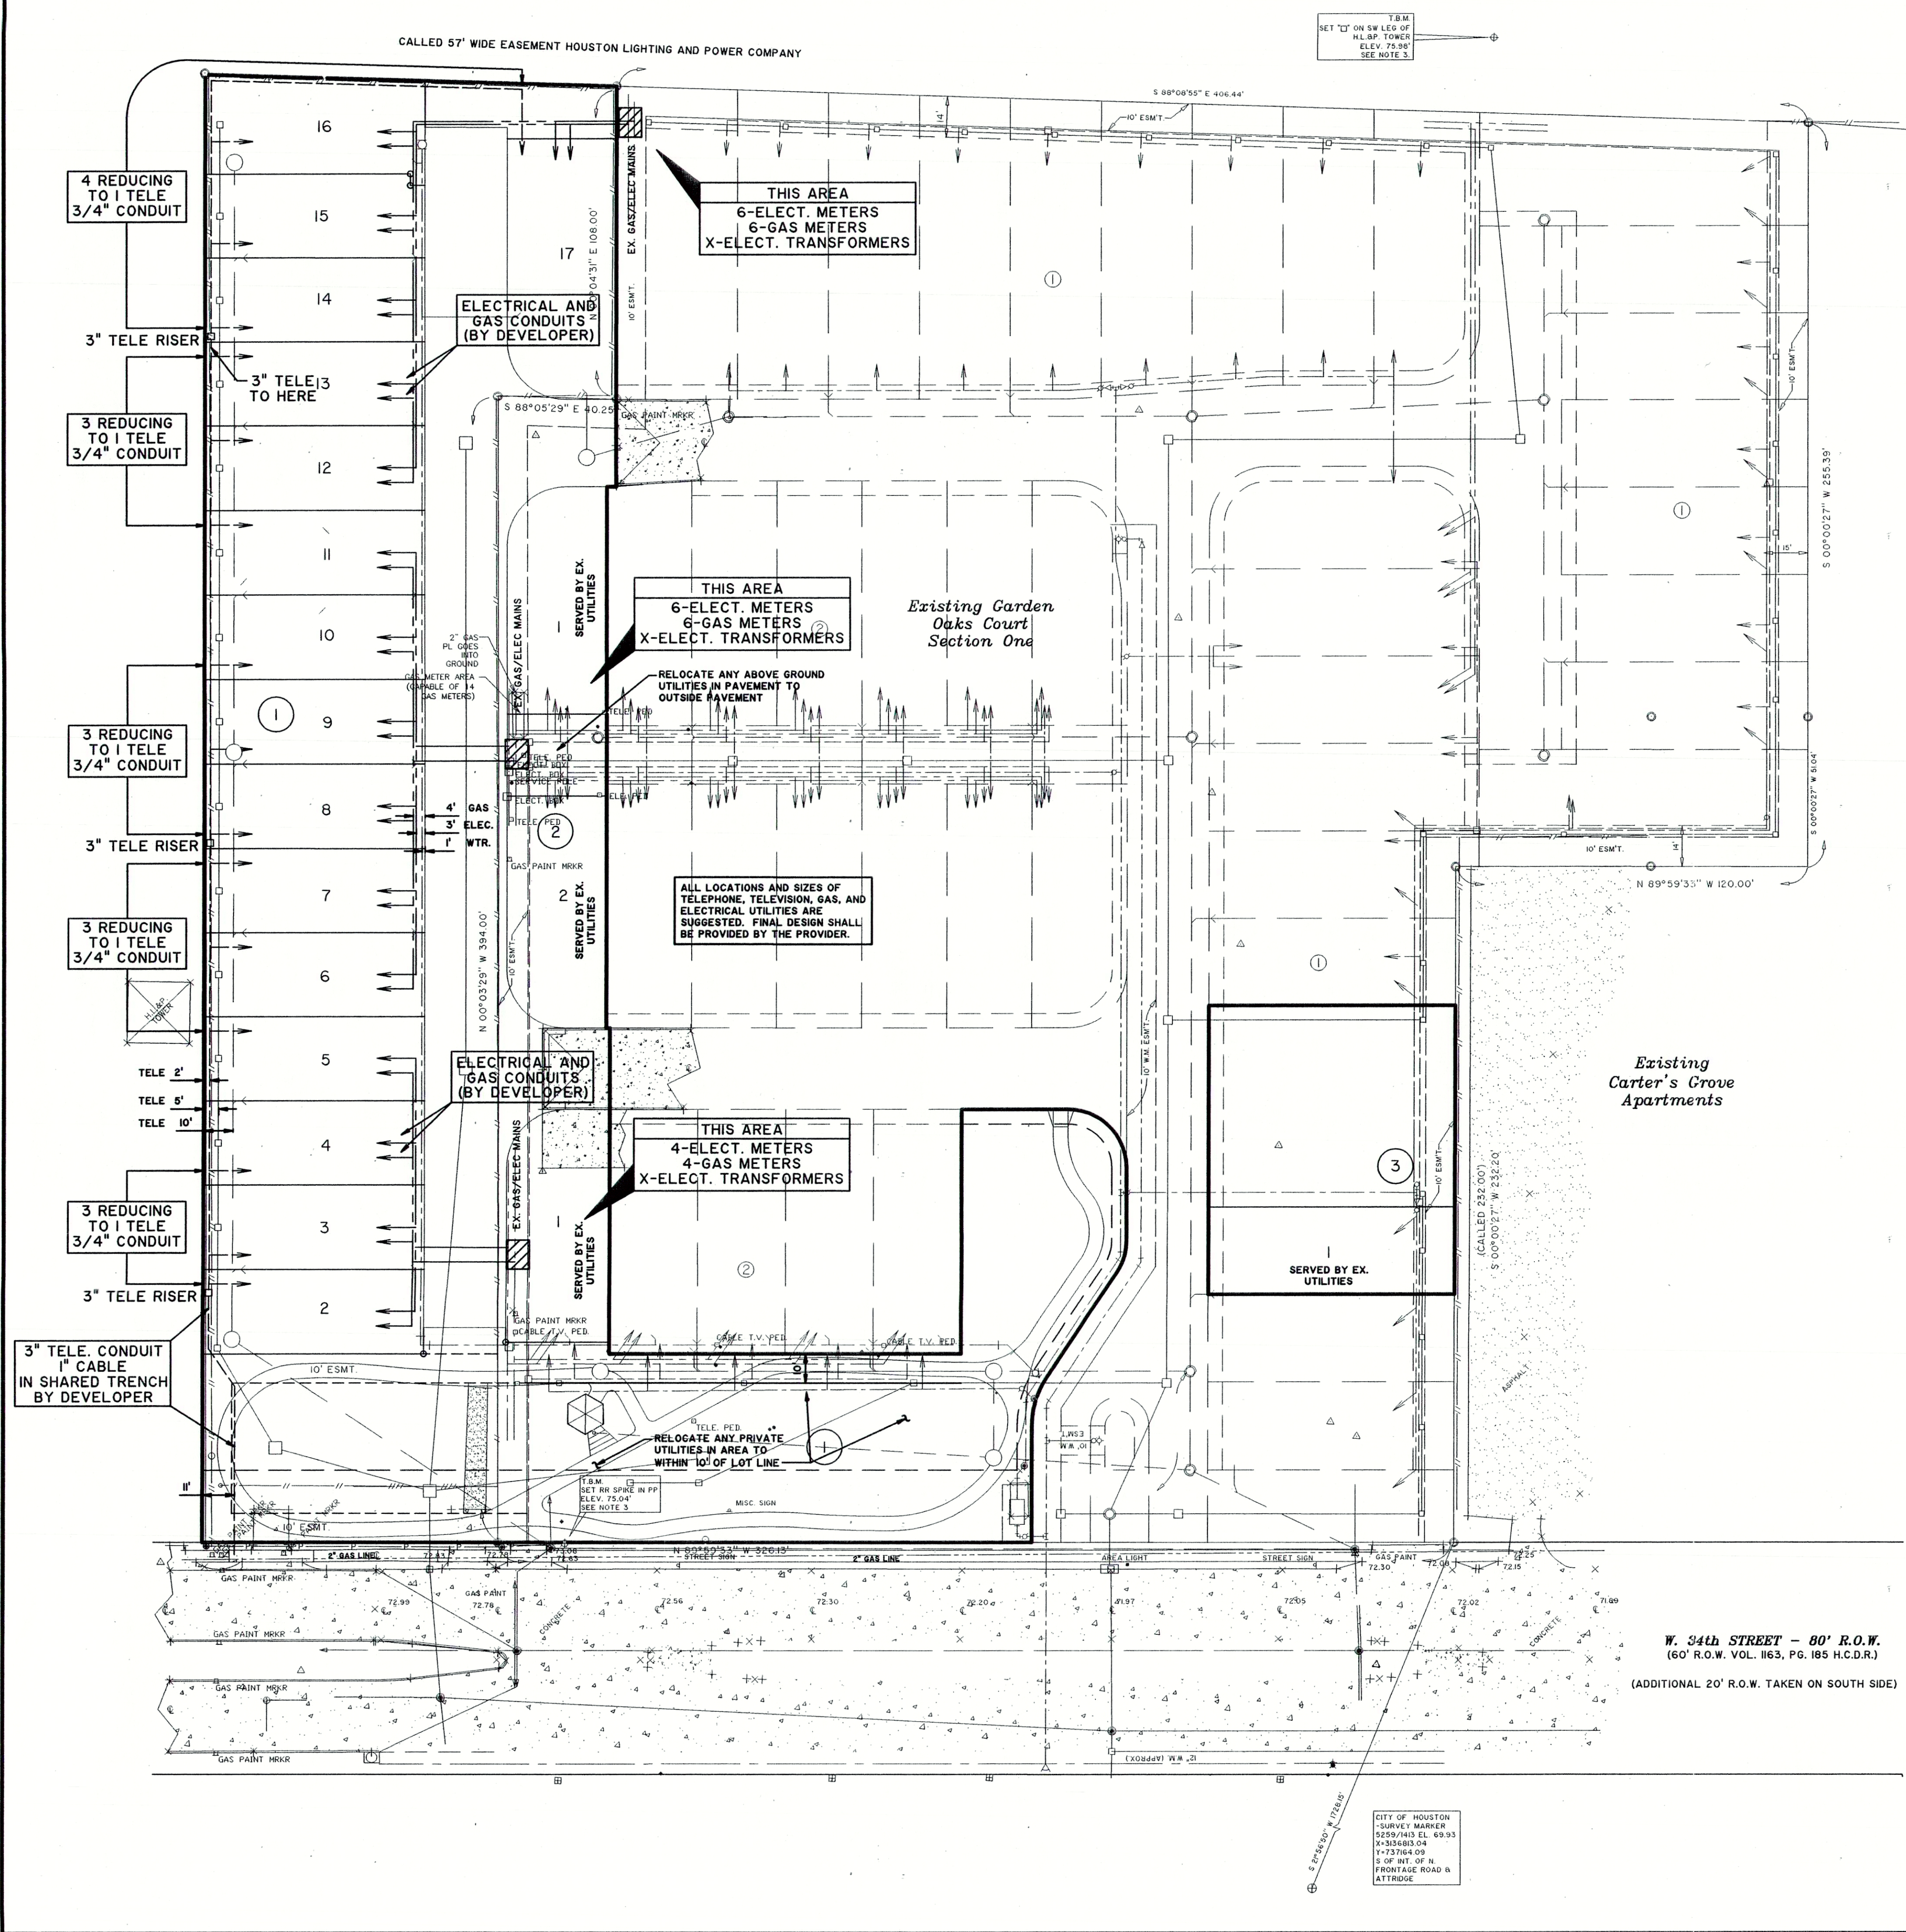


BENCHMARK:
PROJECT BM:
 CITY OF HOUSTON SURVEY MARKER 5259/1413
 ELEV. = 69.93'

FLOOD PLAIN:
TSARP INFORMATION:
 THIS PROJECT LIES WITHIN UNSHADED ZONE "X"
 PER PRELIMINARY TSARP MAPPING FLOOD
 INSURANCE RATE MAP PANEL NO. 48201C0660L
 DATED SEPTEMBER 30, 2004.

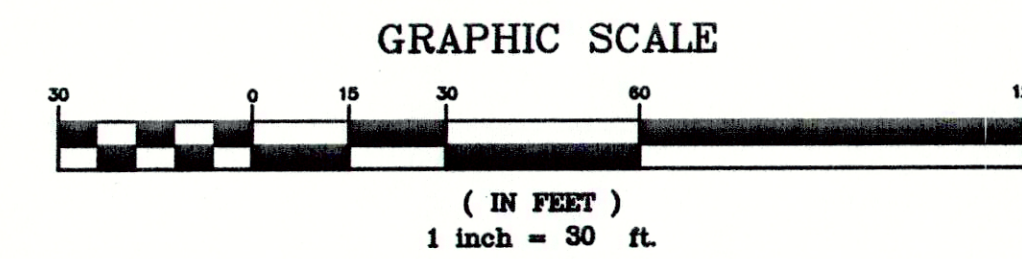

LEGEND

---	TELEPHONE CONDUIT
---	ELECTRICAL CONDUIT
---	GAS LINE
---	WATER MAIN
---	STORM SEWER
---	SANITARY SEWER

C. J. Murgas 8.11.06

REVISIONS	

Carter-Burgess
 Consultants in Planning, Engineering, Architecture
 Construction Management and Related Services
CARTER & BURGESS, INC.
 55 WALSH DRIVE, SUITE 300
 HOUSTON, TX 77007-5842

CITY OF HOUSTON
GARDEN OAKS COURT PARTIAL REPLAT AND
EXTENSION NO. 1 SITE IMPROVEMENTS
PRIVATE
UTILITY PLAN
 ALL LOCATIONS AND SIZES OF TELEPHONE, TELEVISION,
 GAS, AND ELECTRICAL UTILITIES ARE SUGGESTED.
 FINAL DESIGN SHALL BE PROVIDED BY THE PROVIDER.

SCALE: 1" = 30'	PROJ. NO. 030784.050.10010
DESIGNED: N.L.R.	DATE: JULY, 2006
DRAWN: N.L.R.	SHEET: 10 of 15
APPROVED: C.J.M.	

K:\Sdml\m\30784050.dwg\Print\A\921.dwg 7/18/2006 3:08:07 PM CDT